

DOOR WINDOW SCHEDULE			
NAME	WIDTH	HEIGHT	LINTEL LEVEL
D1	1500	2100	0
D2	1100	2100	0
D3	950	2100	0
D4	1100	2100	0
D5	1200	2100	0
D6	1200	2100	0
D7	1200	2100	0
D100	1200	2100	0

TYPICAL 4TH TO 12TH FLOOR PLAN (LV1+17400 TO LV1+43800)

Sl. No	Symbol	Description
1.	①	100ø SOIL PIPE HCL
2.	②	100ø WASTE PIPE HCL
3.	③	75ø VENT PIPE HCL
4.	④	COLD WATER SUPPLY PIPE
5.	⑤	FLUSHING WATER SUPPLY LINE
6.	⑥	150ø RAIN WATER PIPE U/WC
7.	⑦	DOMESTIC WATER SUPPLY RISER
8.	⑧	FLUSHING WATER SUPPLY RISER
9.	⑨	FLOOR CLEAN OUT
10.	⑩	FLOOR CLEAN OUT PLUG
11.	—	WASTE PIPE LINE
12.	—	SOIL PIPE LINE
13.	⊙	FLOOR TRAP
14.	⊙	FLOOR DRAIN
15.	⊙	URINAL TRAP
16.	▨	300X300mm BALCONY R/W KHERRA (TYP.)
17.	▨	450X450mm TERRACE R/W KHERRA (TYP.)

The floor plan shows a rectangular room with overall dimensions of 5780mm by 5690mm. The layout includes a Machine Room TOC (7295mm x 3660mm) with a M1000 fixture, a Water Tank TOC (5480mm x 3410mm) with a M1000 fixture, and a central area with a M1000 fixture. The plan also shows a M1000 fixture, a M1000 fixture, and a M1000 fixture. Dimensions are provided for various sections and fixtures. Material specifications are indicated by codes like WALL TOP AL-4500, AL-4500, and AL-4500.

[illegible]

TERRACE FLOOR PLAN

MUMTY AREA CALCULATION

**REVISED BUILDING PLAN OF
COMMERCIAL COLONY
MEASURING 2.219 ACRES
(LICENCE NO.220 OF 2007 DATED
9.08.2007) IN SECTORE-47
GURGAON, BEING DEVELOPED BY
M/S AUTOMAX (A UNIT OF M/S
ONMAX AUTOS LTD.).**

139

 Architect (P&A) 	 Engineer 	 Surveyor 	 Valuer 	 Officer 	 Member B P.C.
-------------------------	------------------	------------------	----------------	-----------------	-----------------------

S.T. HQ
 In-charge Secretary
 District Office
 Gurgaon
 Haryana








[illegible]

PART	AREA CALCULATION				NO.	TOTAL AREA (SQMT.)
1		5,690	X	7,295	1	41,509
2		3,460	X	2,030	1	7,024
TOTAL AREA					=	48,533

The figure contains two architectural drawings of the Mumty area. On the left is a plan view labeled 'MUMTY AREA DIAGRAM- M1' showing a rectangular area with a diagonal line from the bottom-left corner to the top-right corner. On the right is a section view labeled 'MUMTY AREA DIAGRAM- M2' showing a rectangular area with a diagonal line from the bottom-left corner to the top-right corner. A dimension line indicates a height of 13755 units.

9	11TH FLOOR	40500
10	12TH FLOOR	43800

DWG NO.	08
DRAWING	TYPICAL FLOOR PLAN AND TERRACE PLAN

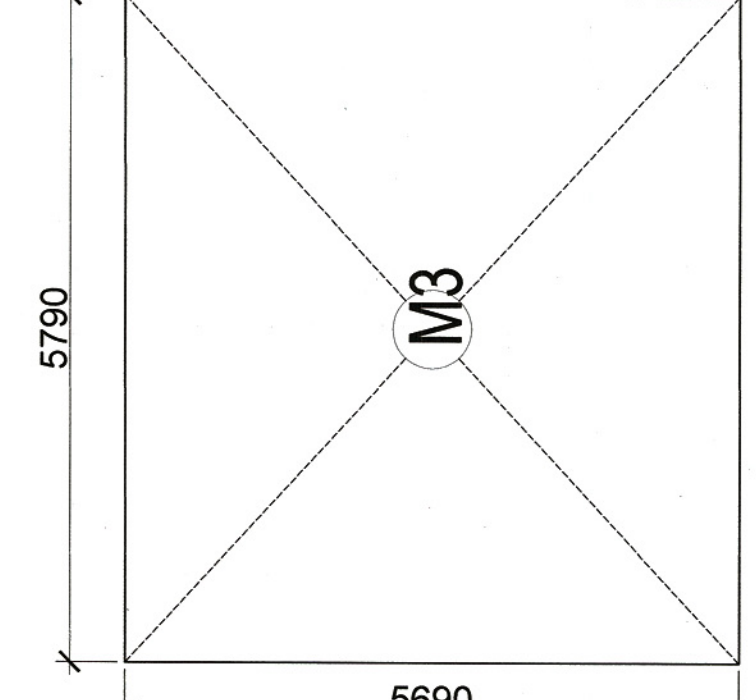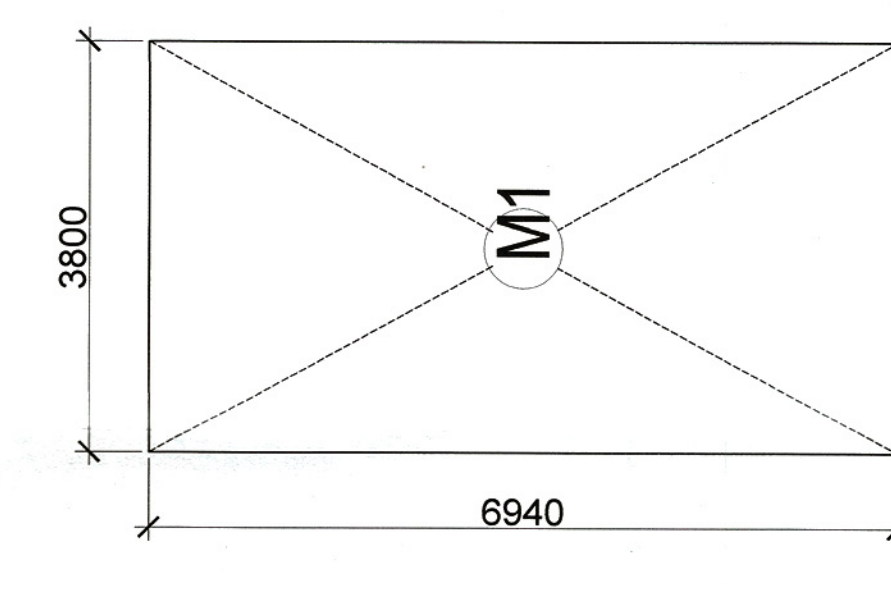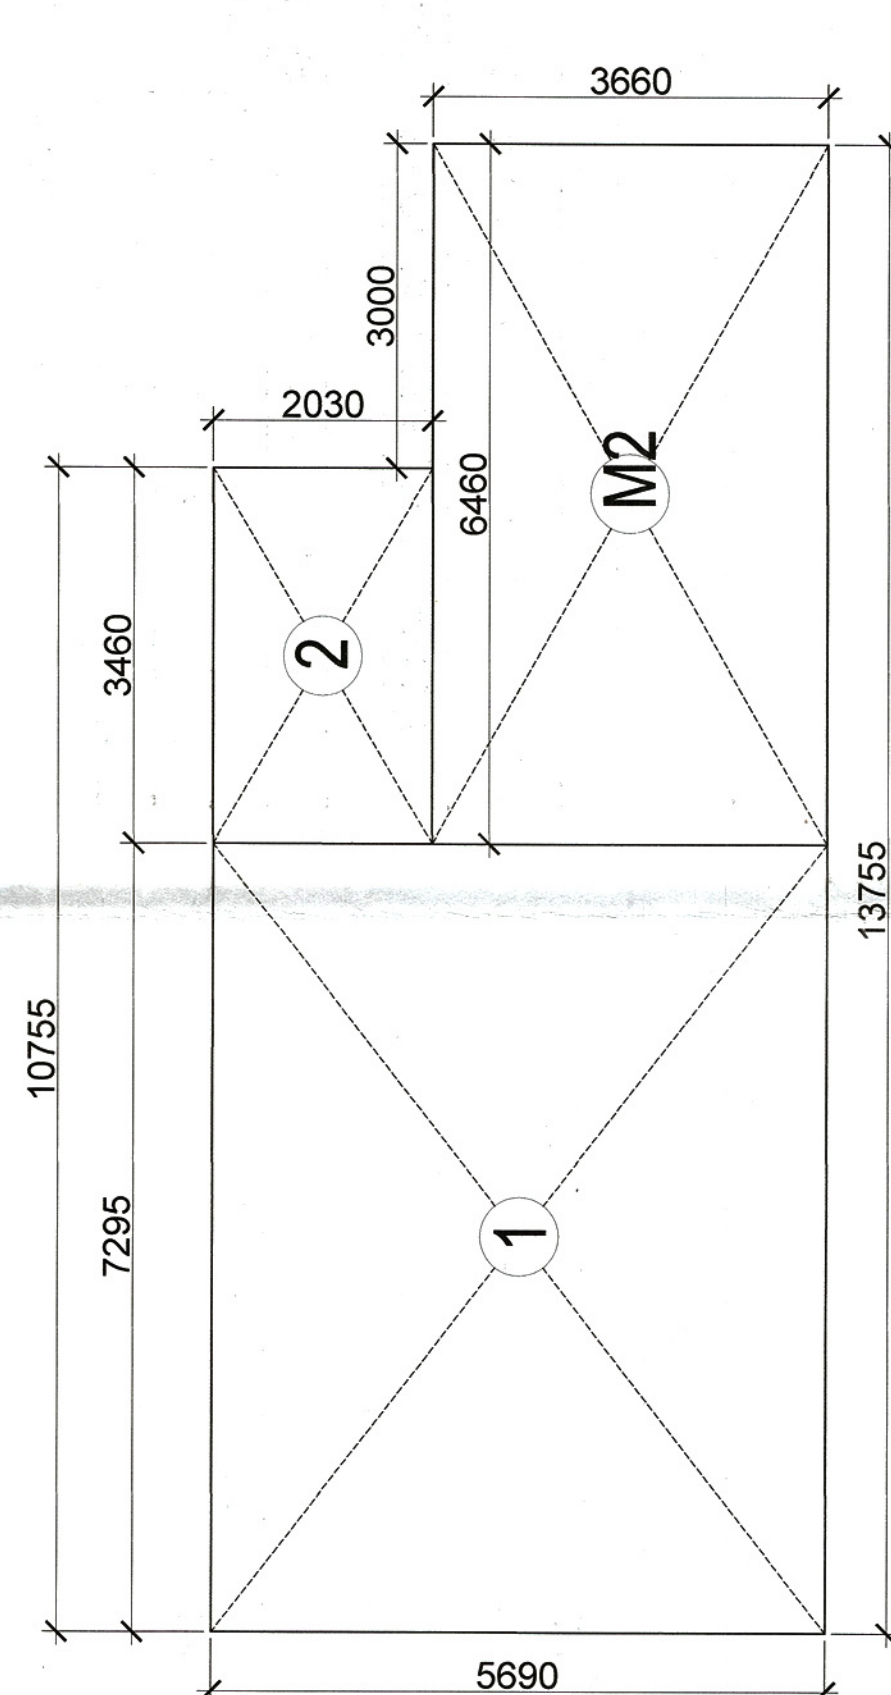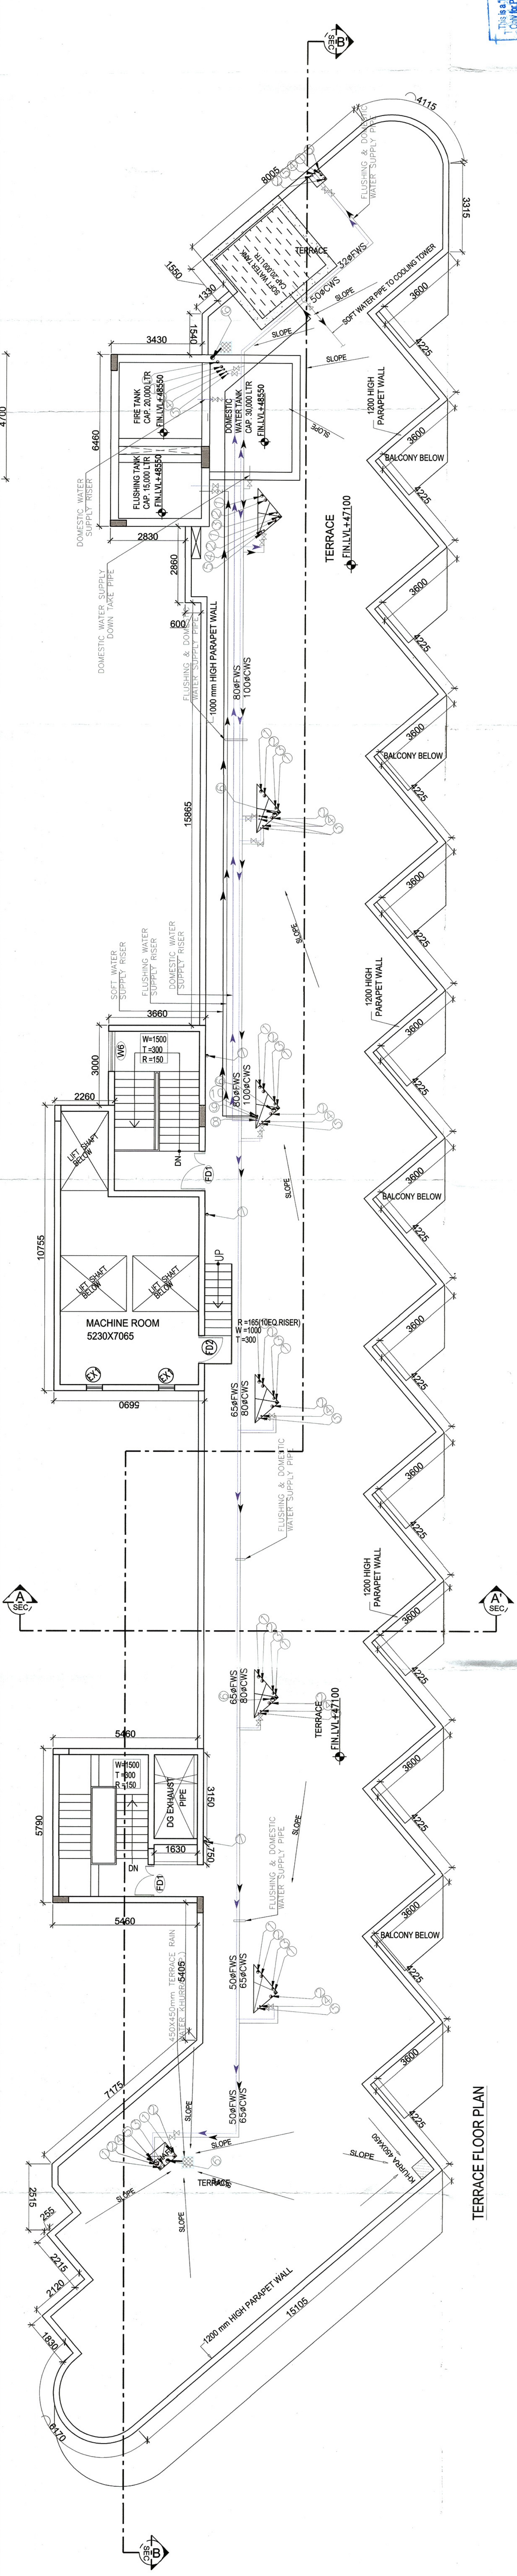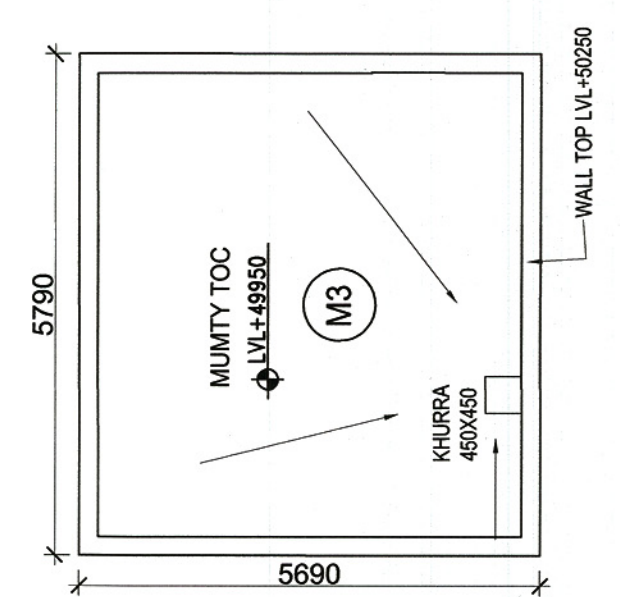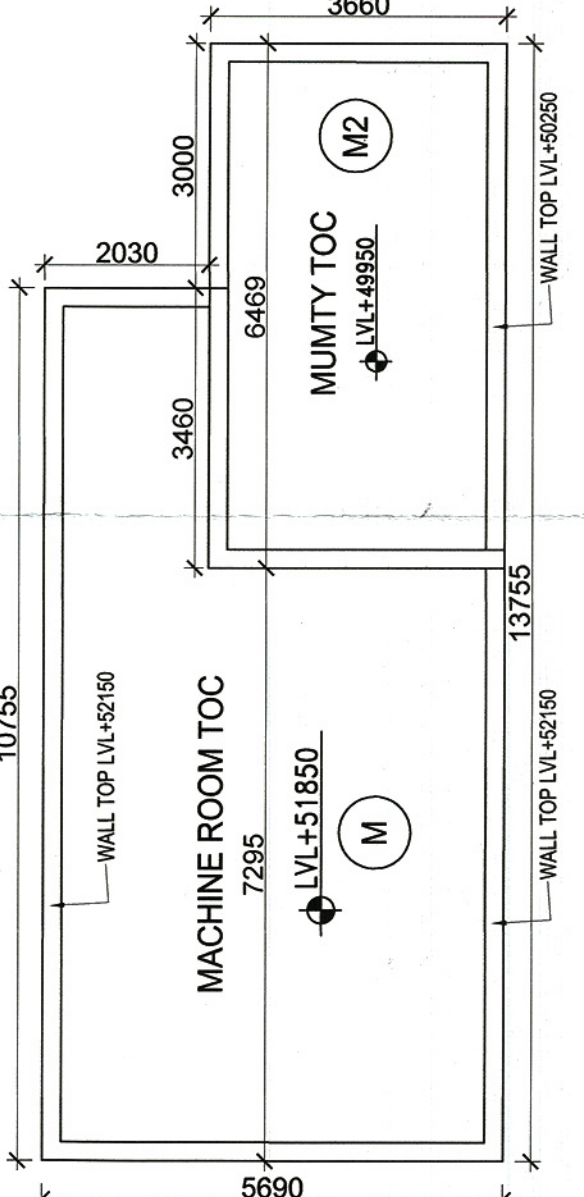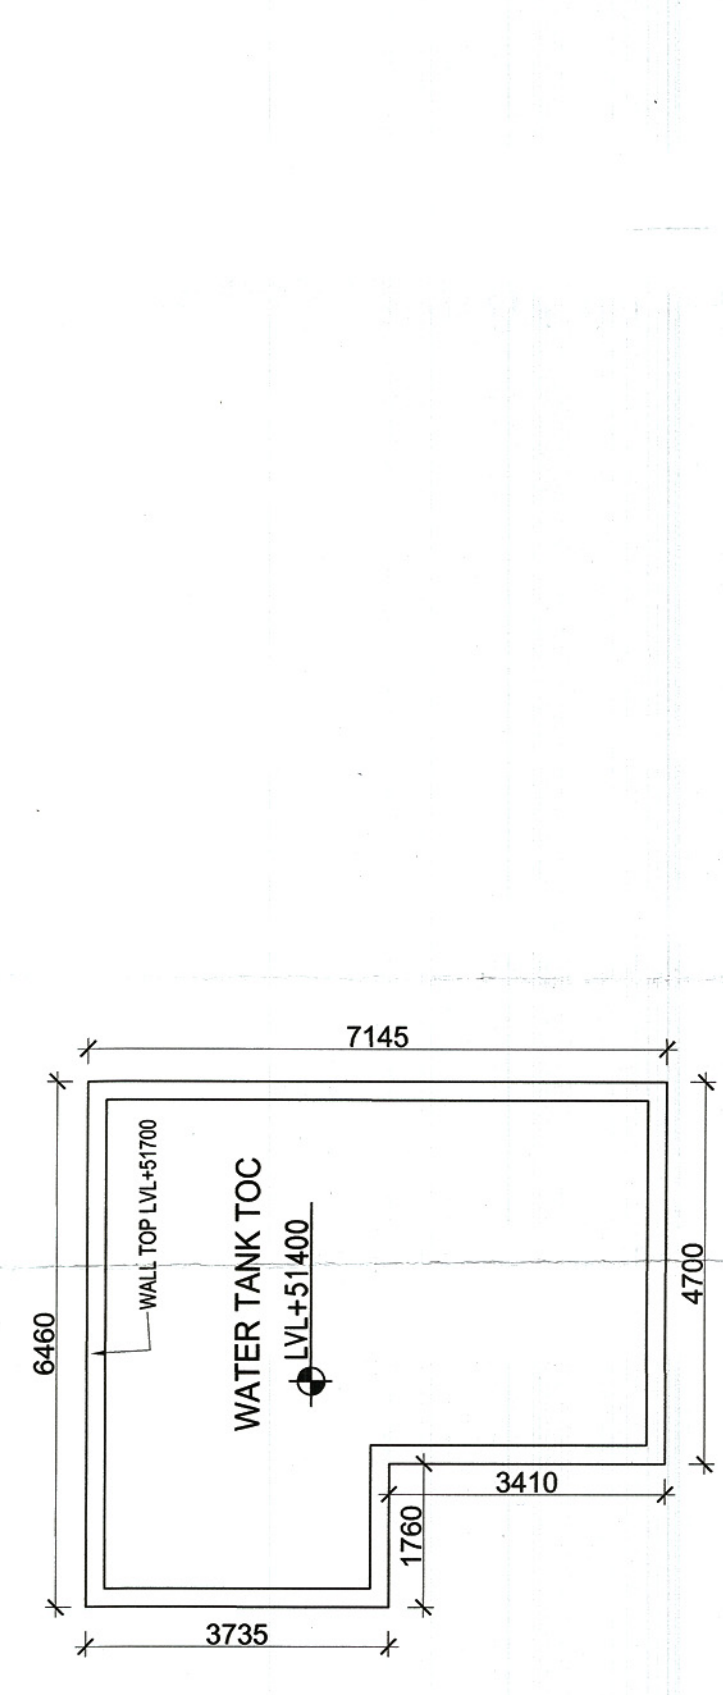

MACHINE ROOM AREA DIAGRAM (M)

MUMTY AREA DIAGRAM- M1

MUMTY PLAN- M3