


20/07/2012
 Member Secretary
 S. P. (C)
 Member
 B.P.C.
 Chairman
 B.P.C.
 10/08/12
 S. P. (C)
 Member
 B.P.C.
 Chairman
 B.P.C.
 10/08/12
 S. P. (C)
 Member
 B.P.C.
 Chairman
 B.P.C.
 10/08/12

SANCTIONED
 To be used in construction with
 reference to drawing No. **2012-13**

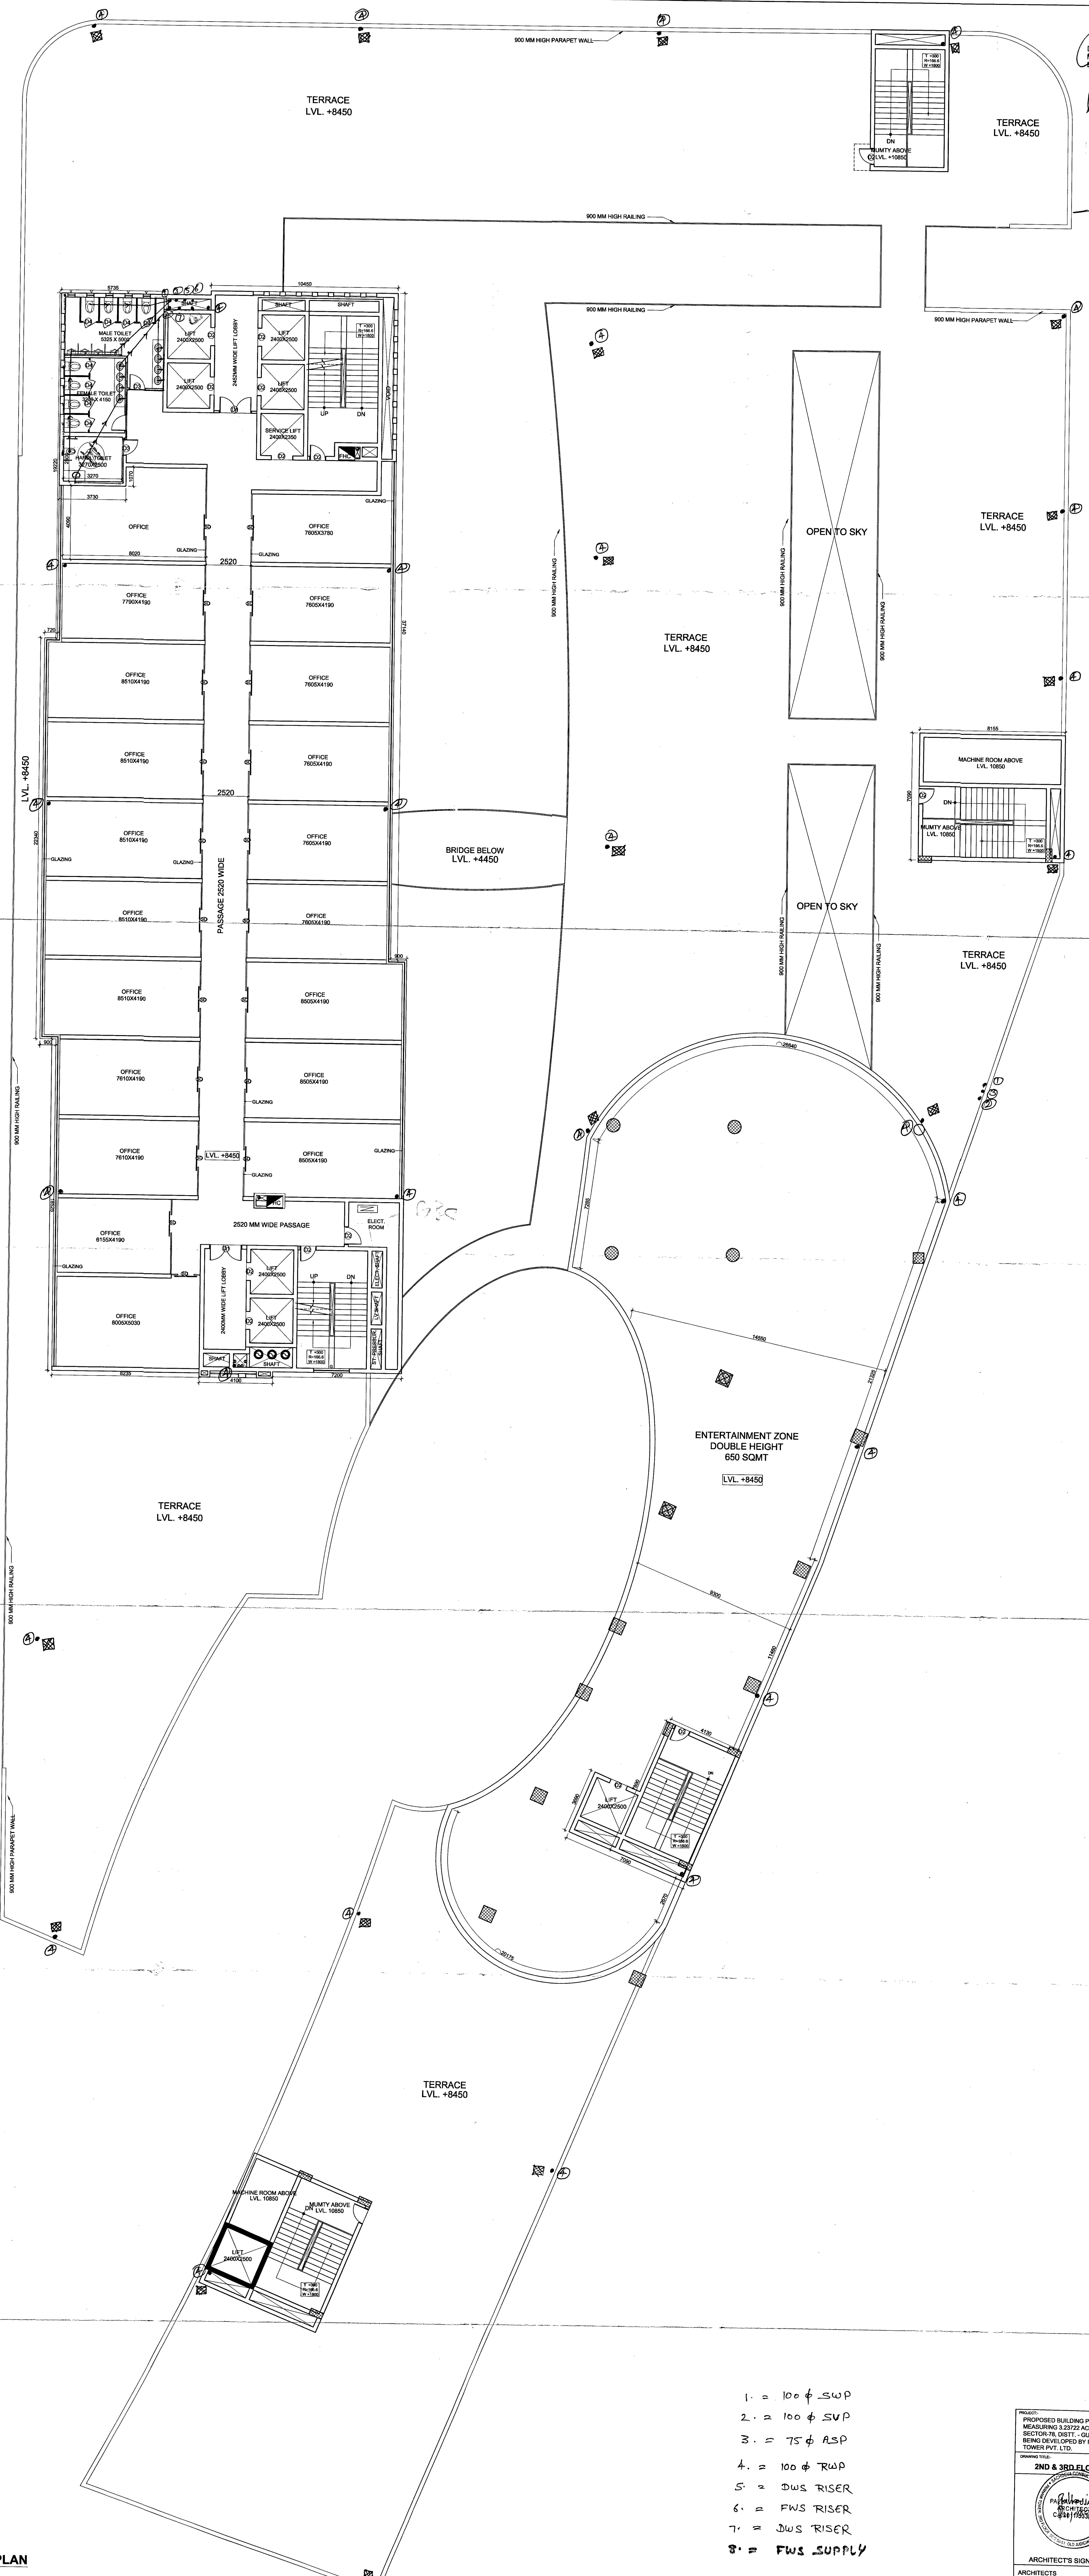

2ND & 3RD FLOOR PLAN

NO.	W/D	HEIGHT	CALL LVL.	INTEL LVL.
D 1	2400	-	2400	
D 1	1800	2400	-	2400
D 2	1000	2400	-	2400
D 3	900	2100	-	2100
D 4	700	2100	-	2100
V 1	400	800	1500	2100
V 2	600	800	1500	2100
W	1800	1800	900	2400
R	2000	2400	-	2400
O	2000	1800	-	2400

- 1. = 100 φ SWP
- 2. = 100 φ SVP
- 3. = 75 φ RSP
- 4. = 100 φ TRAP
- 5. = DWS RISER
- 6. = FWS RISER
- 7. = DWS RISER
- 8. = FWS SUPPLY

2ND & 3RD FLOOR PLAN
 SCALE: 1:100
 SHEET NO: 6

Sachdev Consultants
 ARCHITECTS
 PUNJAB TOWER, 3RD FLOOR, S.C.O. 5041/0-0, D-02, CONNAught
 CH. LANE, DELHI
 TEL: 4348145, 4348146
 E-MAIL: sachs@architects.com