

Refuge Area Calculations

| | | |
|---|----------|------------|
| F.F.L.+49800mm | 1077.198 | 108 |
| F.F.L.+53400mm | 1073.227 | 107 |
| Total Refuge Area to be Provided at 12th Floor | | 215 |

| 12TH FLOOR REFUGE AREA CALCULATION | | |
|------------------------------------|-------|--------------|
| R1 | 12260 | 1500 |
| R2 | 8900 | 1270 |
| R2A | 2395 | 1065 |
| R3 | 8660 | 1500 |
| R4 | 1800 | 875 |
| R5 | 9930 | 1500 |
| R6 | 5145 | 1500 |
| TOTAL | | 7,718 |



| | | | |
|-------|-----|-------|-----------|
| 64.51 | 1.8 | 66.31 | 69.421175 |
|-------|-----|-------|-----------|

12TH FLOOR REFUGE AREA CALCULATION

| | | |
|--------------|-------|--------------|
| R1 | 12260 | 1500 |
| R2 | 8900 | 1270 |
| R2A | 2395 | 1065 |
| R3 | 8660 | 1500 |
| R4 | 1800 | 875 |
| R5 | 9930 | 1500 |
| R6 | 5145 | 1500 |
| TOTAL | | 7,718 |

Architectural Signatures and Stamps:

- ACPL (Architectural Consulting Pvt. Ltd.)
- Dinesh Kumar SD (140) - Architect
- Member B.P.C.G.
- Professional Seal and Stamp

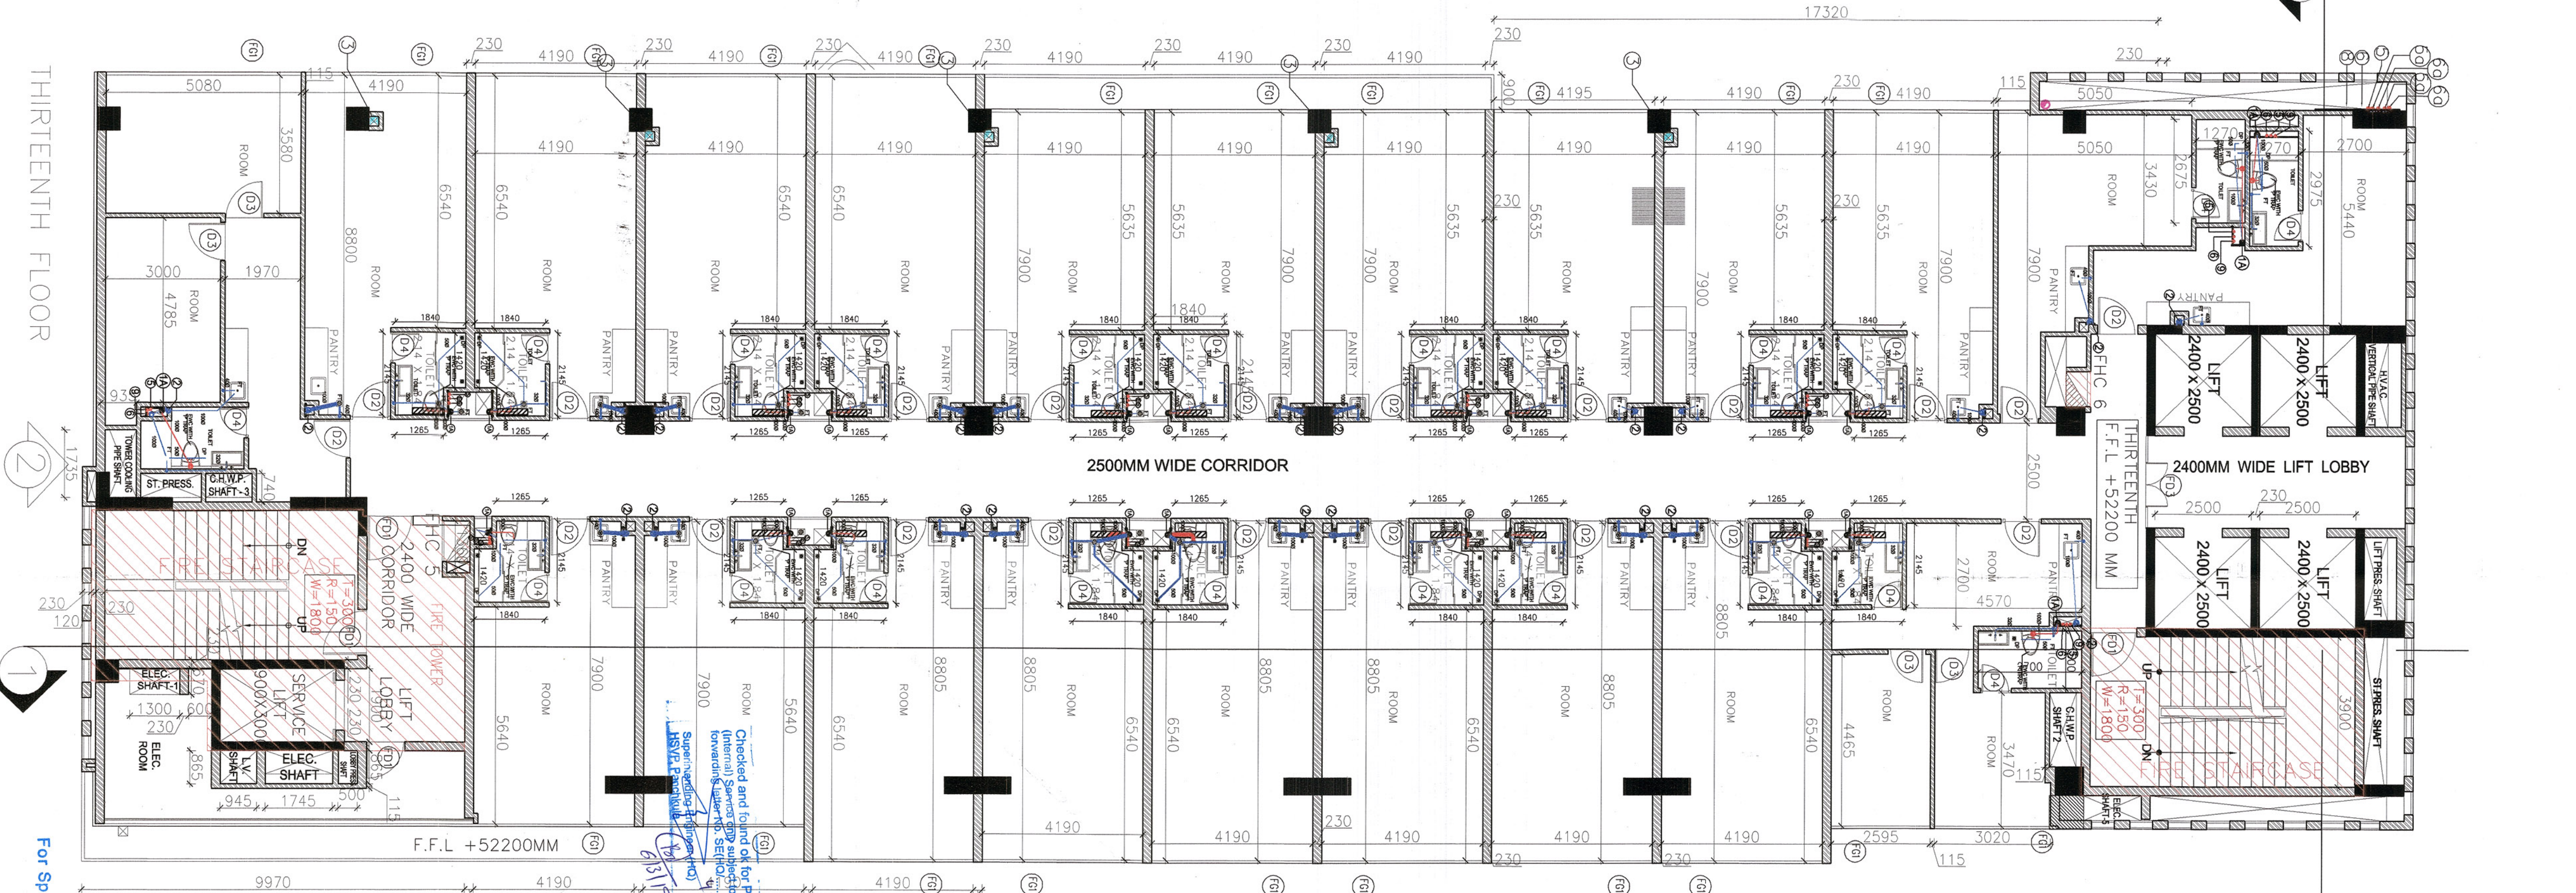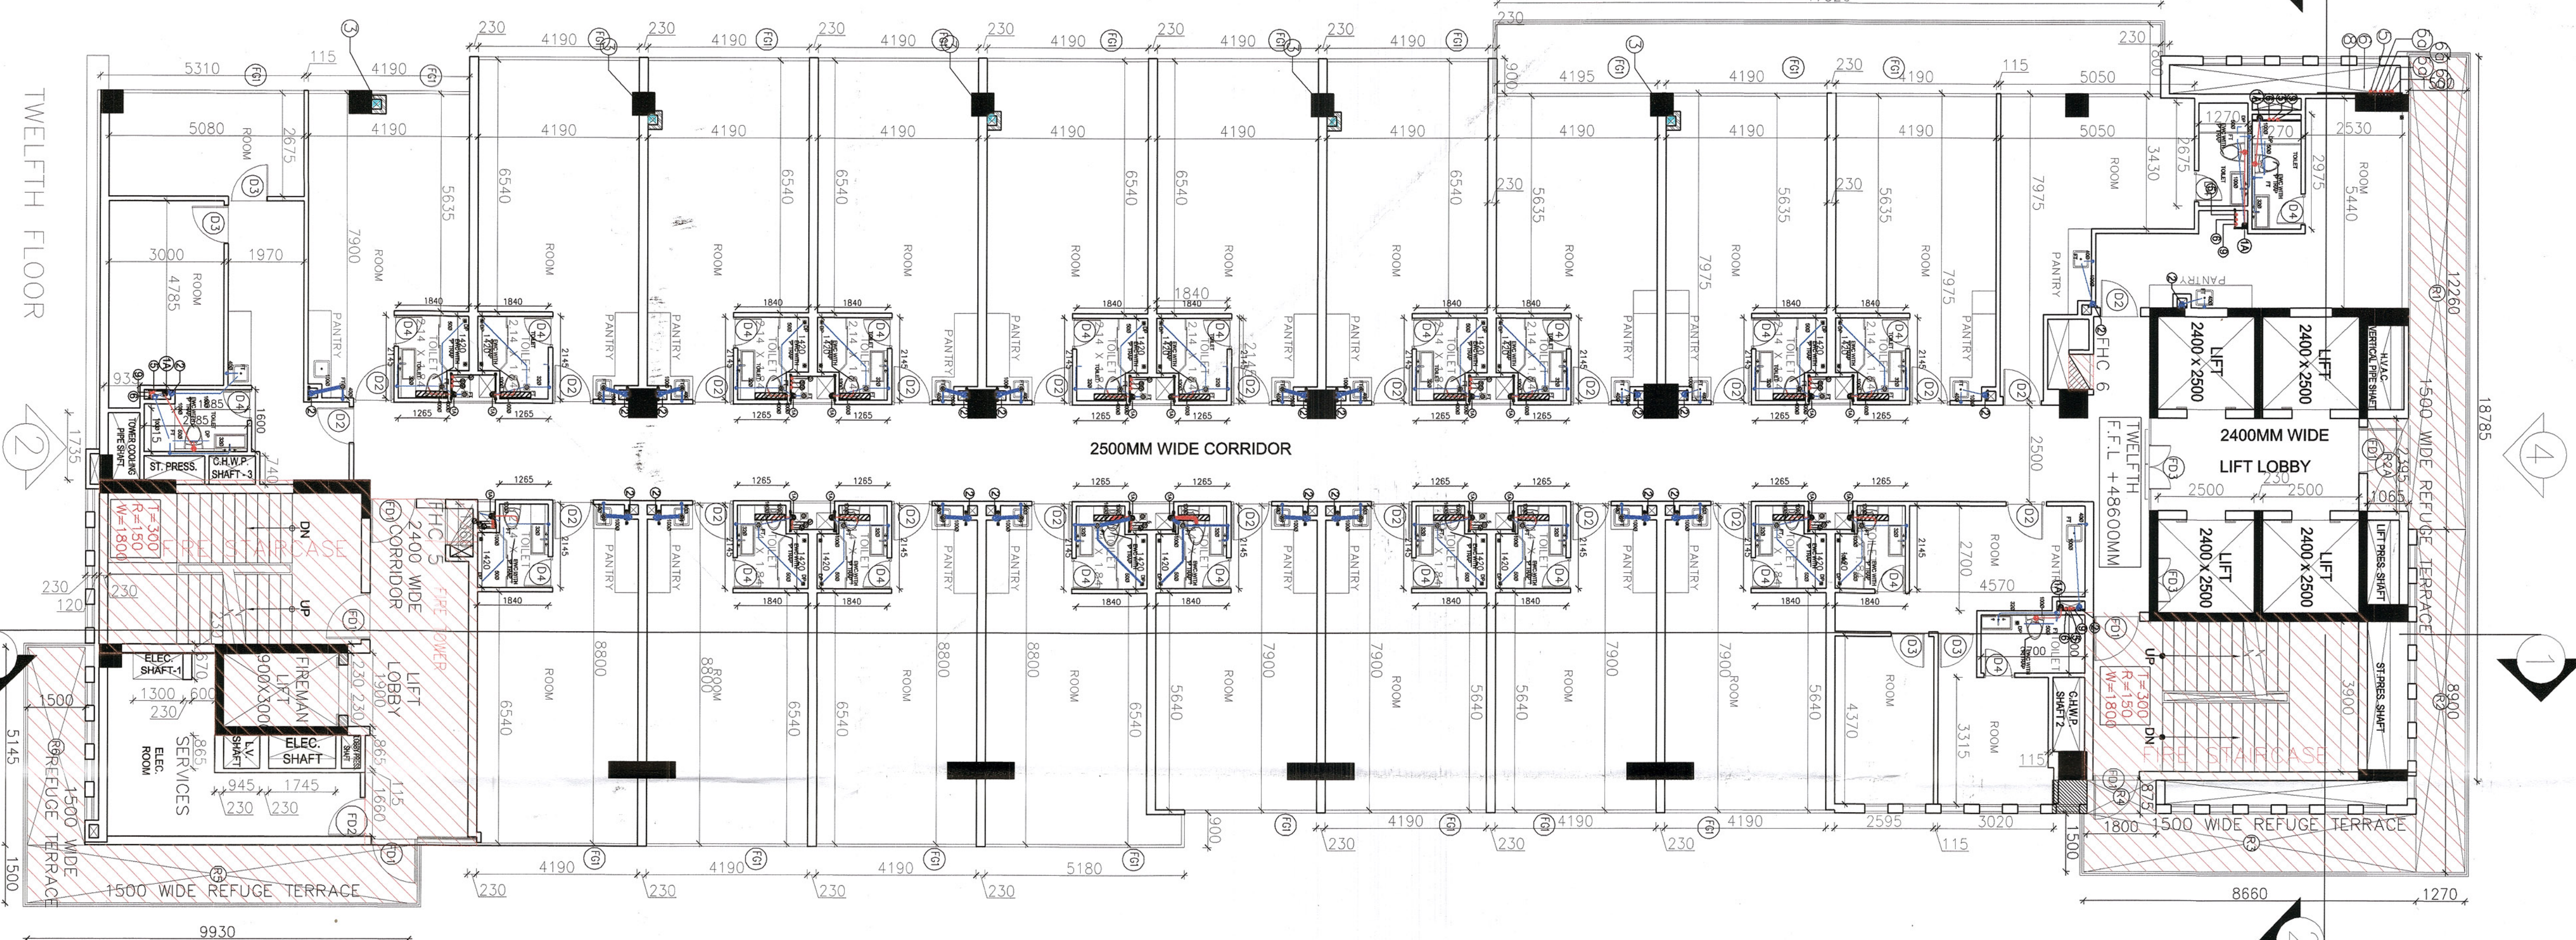

LEGEND

| DESCRIPTION | LEGEND |
|-----------------------------------|--------|
| SOIL AND WASTE VENT PIPE | ⊙ |
| WASTE AND VENT PIPE | ⊙ |
| RAIN WATER PIPE FOR TERRACE | ⊙ |
| RAIN WATER PIPE FOR BALCONY | ⊙ |
| C.M.S INSER FROM O.H.T. | ⊙ |
| F.M.S INSER FROM O.H.T. | ⊙ |
| SOFT WATER SUPPLY INSER TO O.H.T. | ⊙ |
| VENT PIPE | ⊙ |
| H.V.S SMOKE FROM SOLAR TANK | ⊙ |
| FLOOR DRAIN | ⊙ |
| SHOWER | ⊙ |
| SOIL PIPE | ⊙ |
| WASTE PIPE | ⊙ |

12TH & 13TH FLOOR DOOR SCHEDULE

| S.NO. | TYPE | SIZE (IN MM) | LINTEL |
|-------|------|--------------|--------|
| 1 | F01 | 1300 x 2400 | 2400 |
| 2 | F02 | 1000 x 2400 | 2400 |
| 3 | D1 | 1200 x 2100 | 2100 |
| 4 | D2 | 1000 x 2100 | 2100 |
| 5 | D3 | 750 x 2100 | 2100 |
| 6 | D4 | 650 x 2100 | 2100 |
| 7 | G11 | 1200 x 2400 | 3000 |
| | S11 | 1000 x 2100 | |
| | F01 | | |

ACPL (Architectural Consulting Pvt. Ltd.)

Principal Architect: Dinesh Kumar SD (140)

Project: TWELFTH & THIRTEENTH FLOOR PLAN

Scale: 1:100

Architectural Signatures and Stamps:

- ACPL (Architectural Consulting Pvt. Ltd.)
- Dinesh Kumar SD (140) - Architect
- Member B.P.C.G.
- Professional Seal and Stamp